



**MORTON
VERGES
ARCHITECTS**

4840 S. CARROLLTON AVE.
NEW ORLEANS, LA. 70119
PHONE: (504) 488-7760
FAX: (504) 488-7763
MVA@MORTONVERGES.COM

**STUDENT LIFE CENTER
DELGADO COMMUNITY COLLEGE**

CITY PARK AVENUE
NEW ORLEANS, LA


REVISIONS:

JOB NO. **9511**

DATE: 4/28/01
DRAWN: LSM
CHECKED: CY

SHEET NO. **1**
1 OF **2**

03/11/01, 11/17

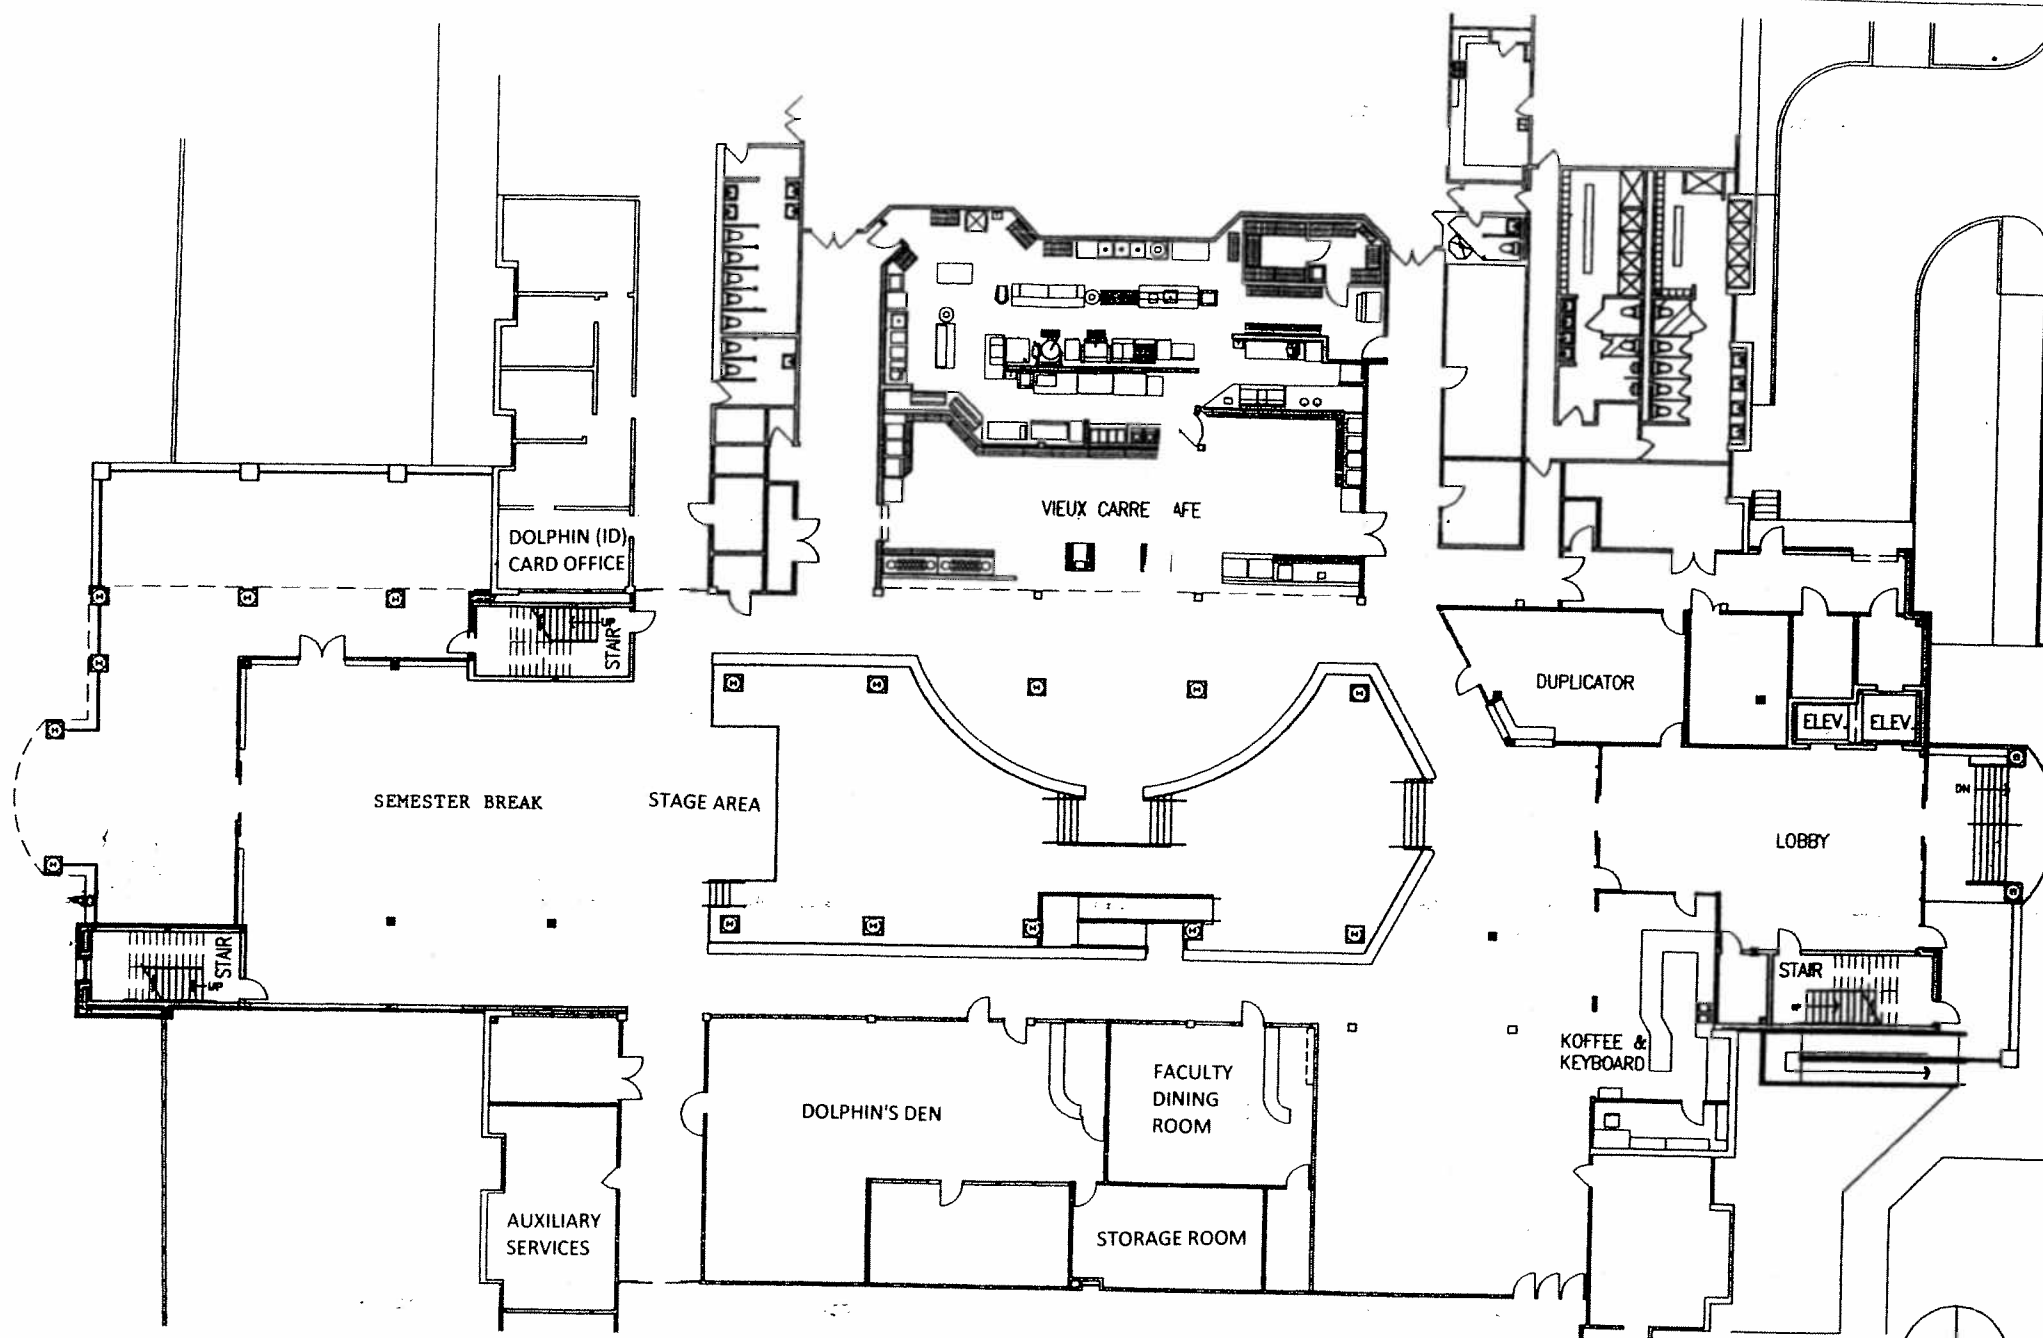

FIRST FLOOR PLAN
1" = 20'-0"

